


DO NOT SCALE PRINT

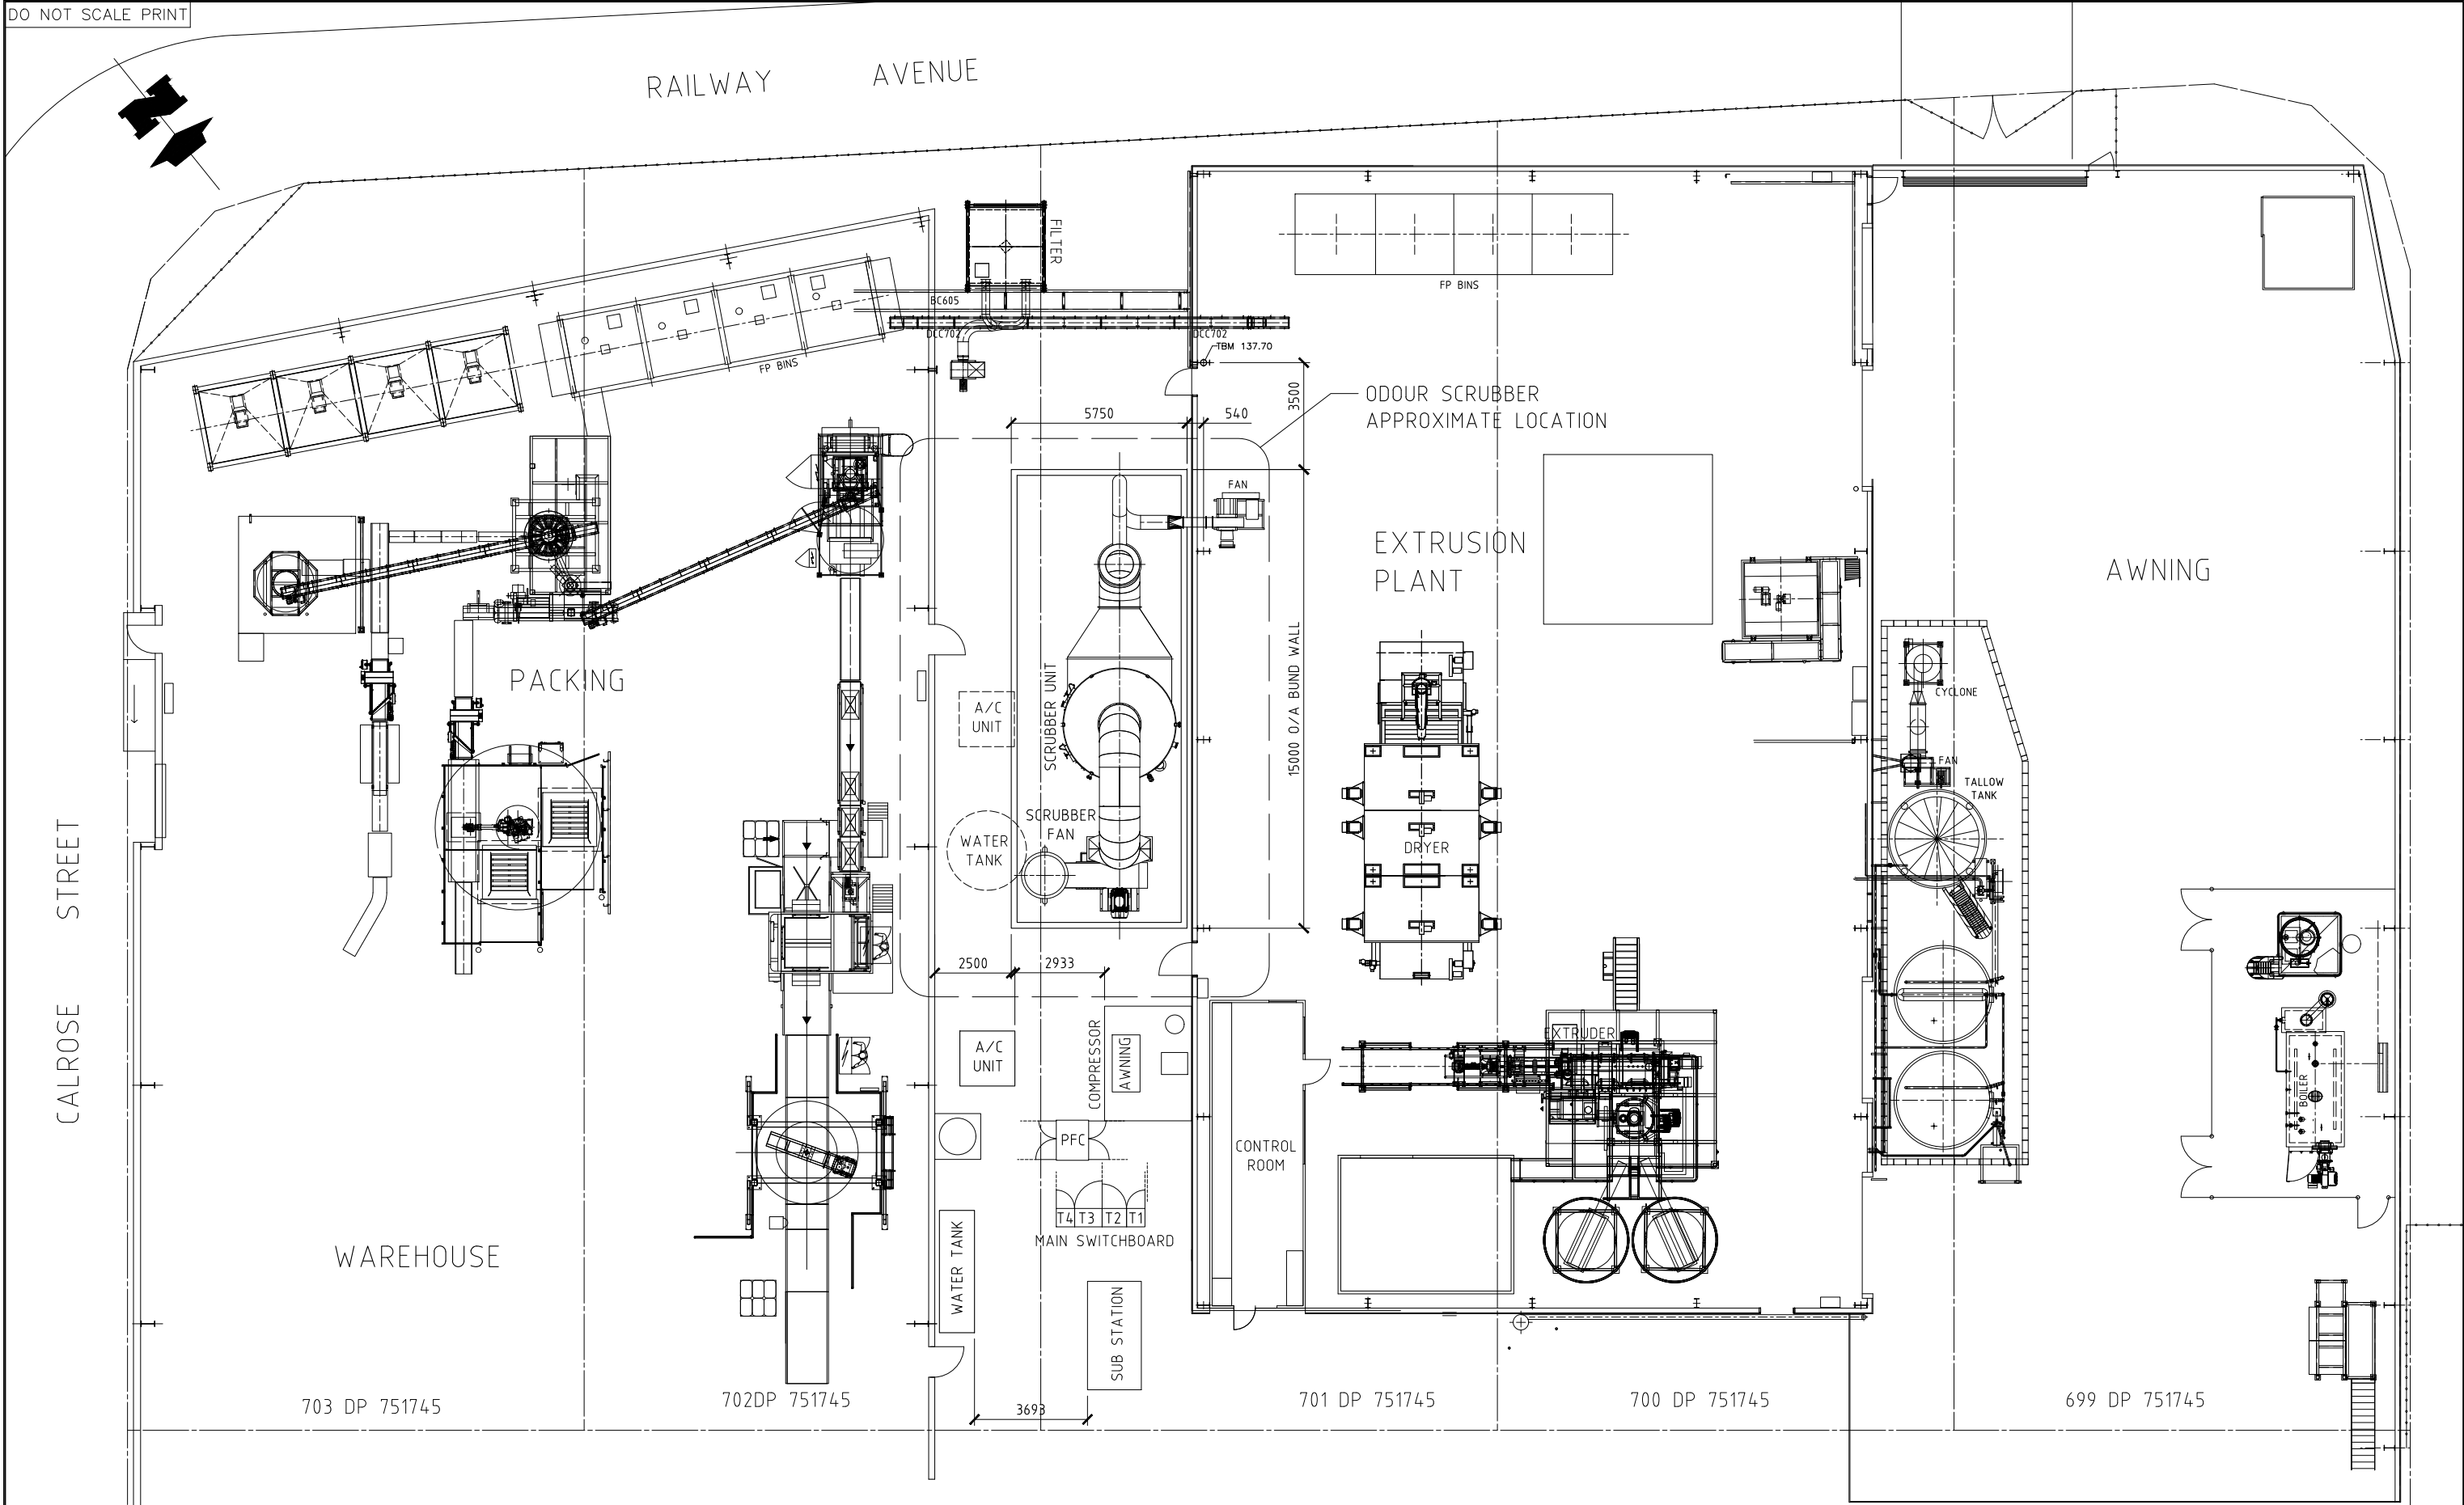

FLOOR PLAN AT FL137.700 TOC

A	12/3/2025	ISSUED FOR DISCUSSION	BFR	A.V.	
ISSUE	DATE	DESCRIPTION	BY:	APPROVED	

THIS DRAWING REMAINS THE PROPERTY OF RICEGROWERS LIMITED.
THE DRAWINGS AND DESIGN SHOWN ARE COPYRIGHT AND IS
ISSUED ON THE UNDERSTANDING THAT IT WILL NOT BE COPIED,
REPRODUCED, PRODUCED FROM OR USED IN ANY WAY, IN WHOLE
OR PART, WITHOUT THE WRITTEN CONSENT FROM THE COMPANY.

Ricegrowers
RICEGROWERS LIMITED
A.B.N. 55 007 481 156

ENGINEERING DIVISION
Yanco Ave., Leeton
N.S.W. 2705, Australia
Locked Bag 2
Telephone: 02 6953 0411
Email: eng@sunrice.com.au

TITLE:
ODOUR SCRUBBER SYSTEM INSTALLATION
EQUIPMENT & SERVICES LOCATION
PLAN LAYOUT AT FL137.700TOC

PROJECT No.	ISSUE No.
DRAWING No.	A
60637	

DRAWN: BFR	DATE: 10/3/2025	CHECKED:	SCALE: 1:100 (A1) UNO	LOCATION: LEETON	FACILITY: COPRICE	SECTION: SPECIALTY PRODUCT
------------	-----------------	----------	-----------------------	------------------	-------------------	----------------------------