
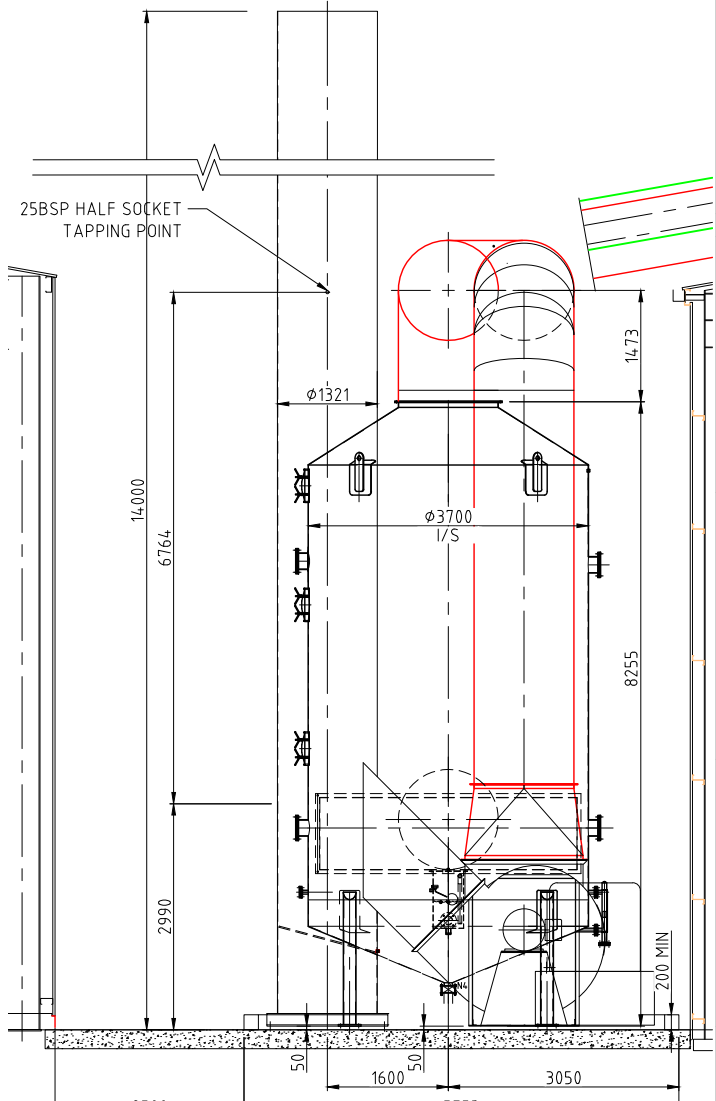
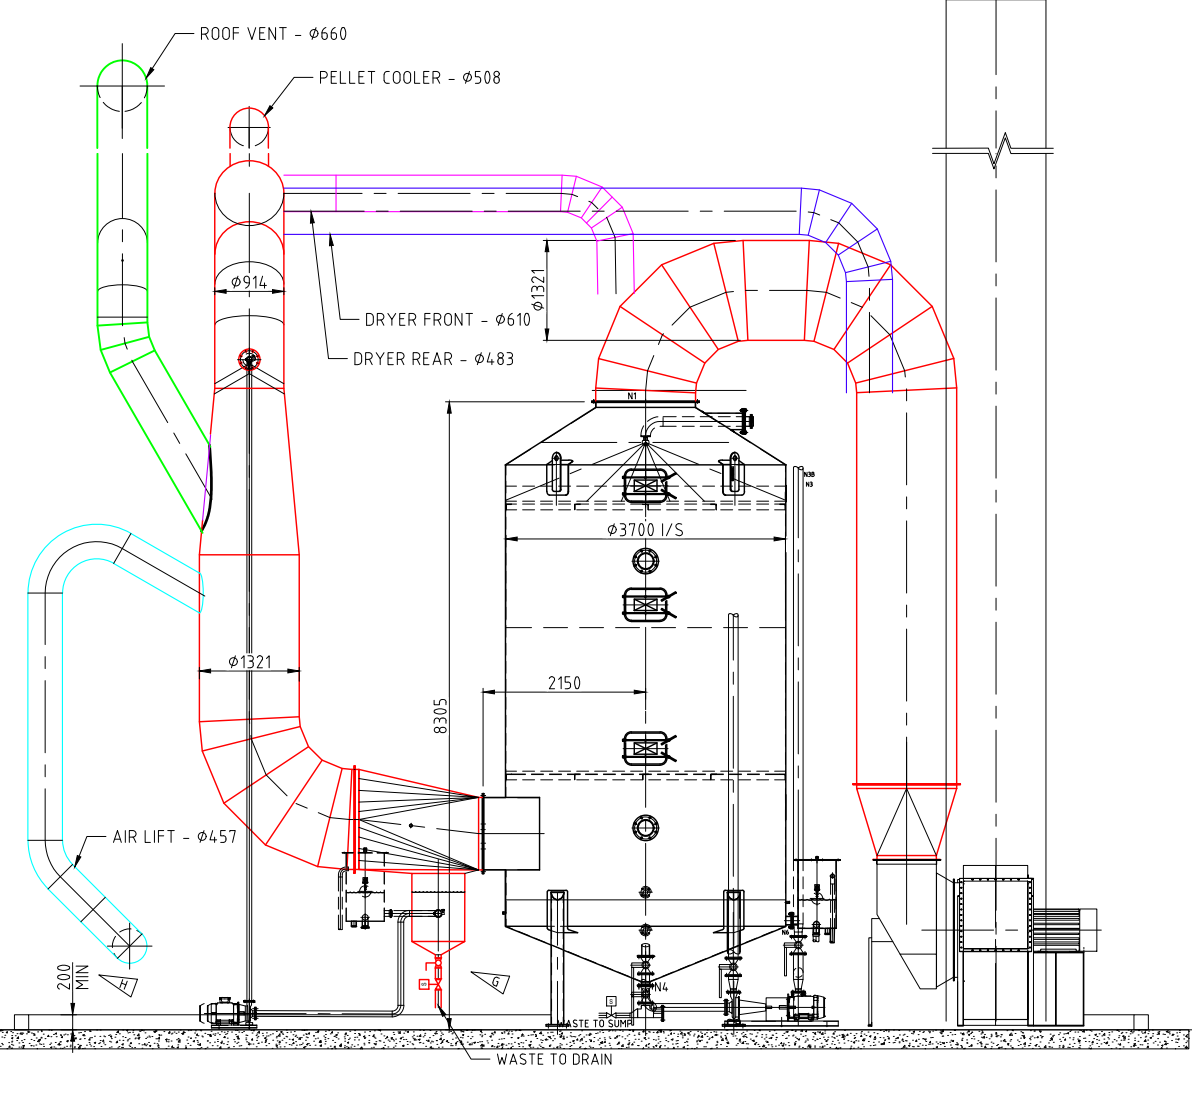
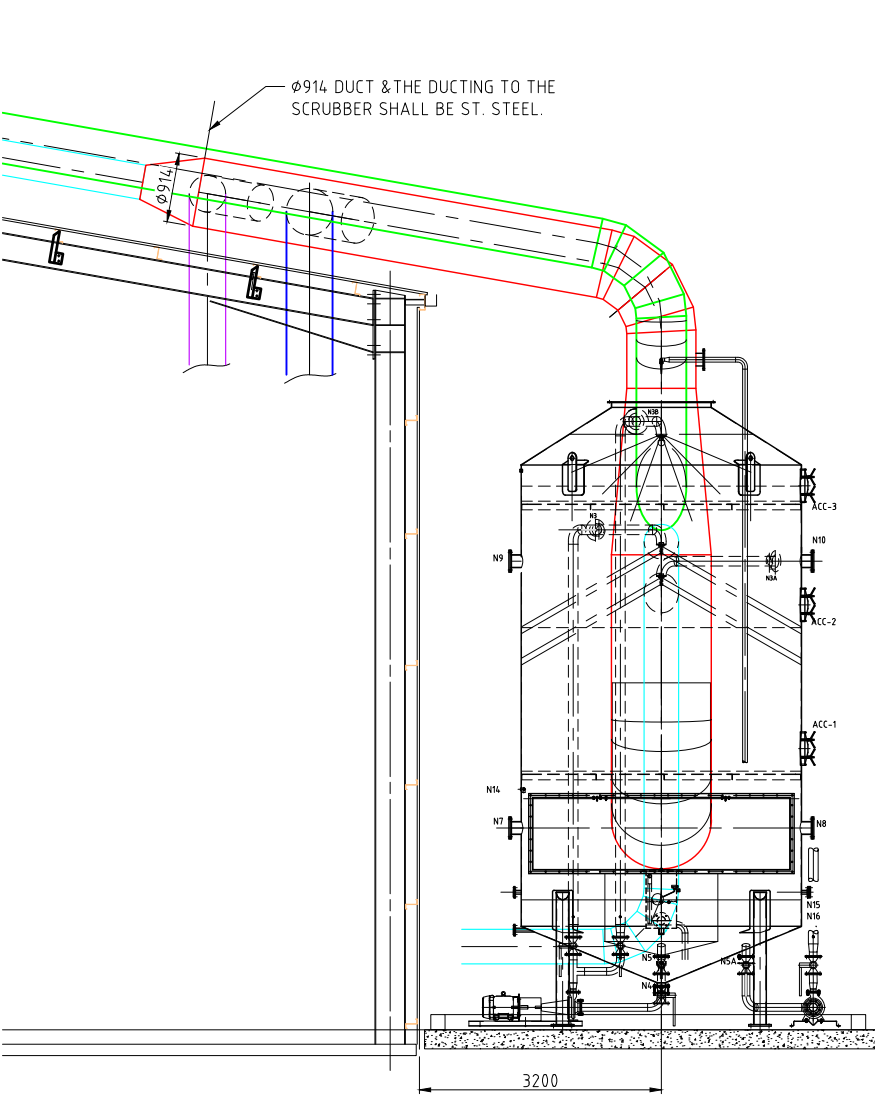


A
B
C
D
E
F
G
H

A
B
C
D
E
F
G
H

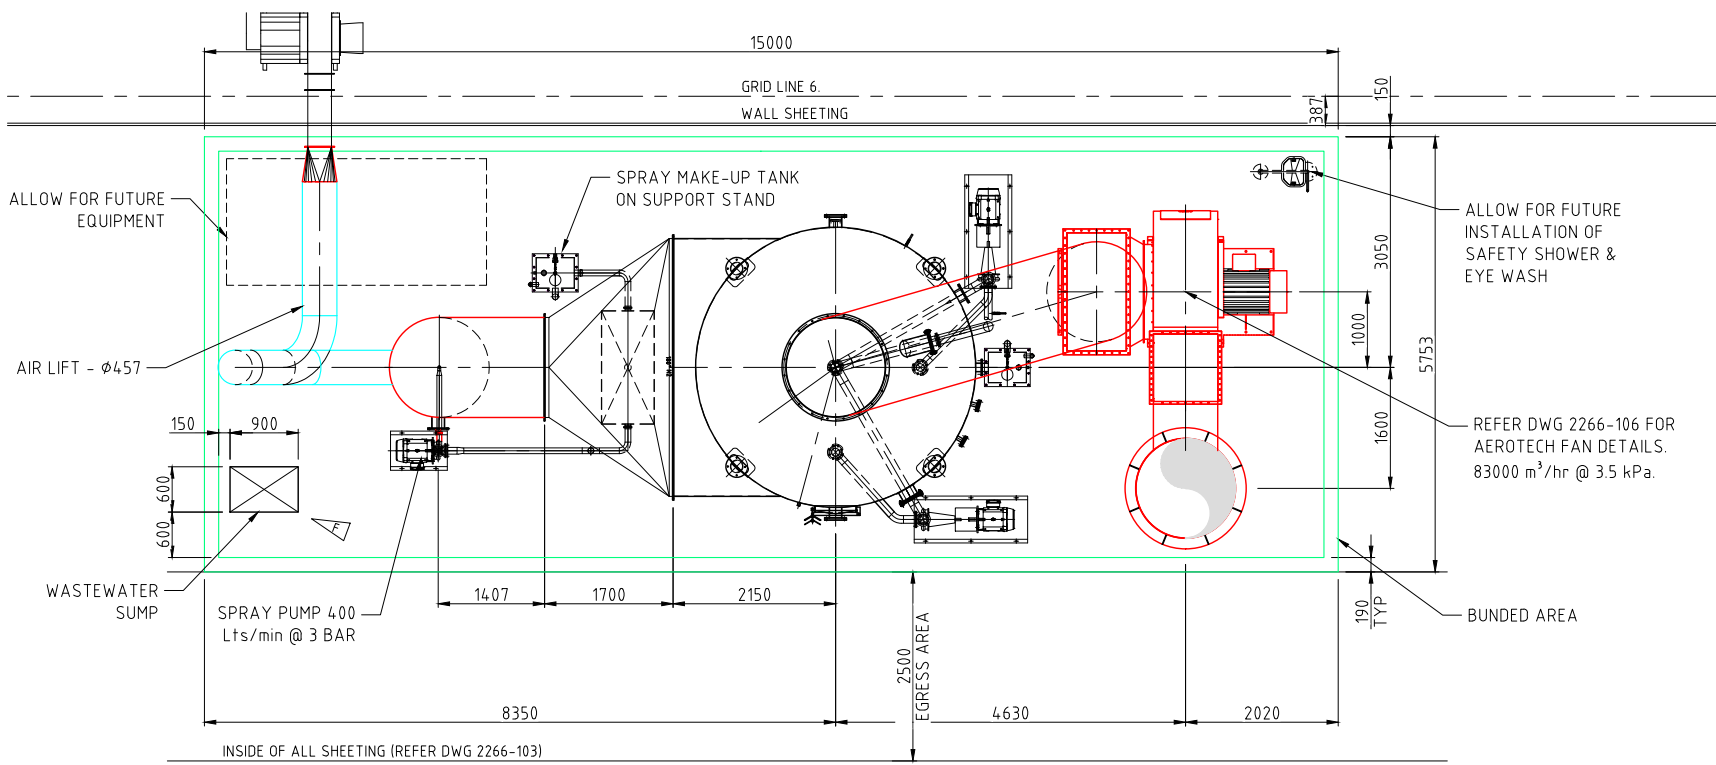

DRG No.	TITLE	REV	BY	DATE	A.R.N.	DESCRIPTION
2266-106	FAN ARRANGEMENT, 83000 m ³ /hr @ 3.5 kPa VSD					
2298-105	AIR SCRUBBER SYSTEM ELEVATIONS ON GRID E					
2298-104	AIR SCRUBBER SYSTEM ELEVATIONS ON GRIDS C & D					
2298-103	AIR SCRUBBER SYSTEM GENERAL ARRANGEMENT					
2266-101	AIR SCRUBBER SYSTEM P & ID					
2266-100 SHEET 2	SCRUBBER ARRANGEMENT SHT 2					
2266-100 SHEET 1	SCRUBBER ARRANGEMENT SHT 1					

REV	BY	DATE	A.R.N.	DESCRIPTION
H	W.W.	16-11-24		BUNDS CHANGED TO 200 MIN
G	W.W.	17-09-24		SUMP UNDER DUCT, ADD MAN VLV & CHANGE VLV TO SOL VLV
F	W.W.	8-08-24		WASTEWATER SUMP ADDED, SUMP UNDER DUCT ALTERED
E	W.W.	6-08-24		UPDATED TO CURRENT REQUIREMENTS
D	W.W.	29-07-24		DUCTING TO SCRUBBER ALTERED, COMPONENTS DELETED.
C	W.W.	1-07-24		LAYOUT UPDATED TO CLIENT REQUEST
B	W.W.	25-04-24		SCRUBBER, DUCTING & FAN UPDATED



THE ODOUR UNIT PTY LTD

www.odourunit.com.au

12/ 56 Church Ave. Mascot. NSW. 2020

Ph: (02) 9209 4420

This design remains the property of The Odour Unit Pty Limited and may not be reproduced or used without permission. © Copyright The Odour Unit Pty Ltd.

DRAWN TO	SCALE
AS 1100	1: 50 (A1) U.N.O.
DRAWN	W. WESTWOOD. 17-08-21
CHECKED	
APPROVED	M. ASSAL
DESIGN ENG	W. WESTWOOD. 17-08-21

CLIENT / PROJECT	COPRICE RAILWAY AVE, LEETON, NSW, 2705.	DRAWING No	2266-102	REV	H
TITLE	COPRICE MILL, LEETON PROPOSED PLANT UPGRADE AIR SCRUBBING EQUIPMENT GENERAL ARRANGEMENT	CLIENT CODE	N2266	JOB No.	N2266
		AutoCAD FILENAME	2266-102H.DWG		